 













ANZAC PARK EAST

BLOCK 2 SECTION 4 PARKES


ELECTRICAL SERVICES

SYMBOL	IMAGE	DESCRIPTION
 P1		POLE TOP LIGHTING
 L2		WALL/SCULPTURE UPLIGHT
 L3		ARBOUR FRAME LINEAR DOWNLIGHT
 L4		TREE UPLIGHTING
 L5		RECESSED WALL LIGHT
 L6		CATENARY LIGHTING

GENERAL NOTES

- LIGHTING PROPOSAL COMPLIES TO AS1158.3.1 PEDESTRIAN AREA (CATEGORY P) LIGHTING PERFORMANCE AND DESIGN REQUIREMENTS.
- LIGHTING PROPOSAL COMPLIES TO AS 4282-1997 CONTROL OF THE OBTRUSIVE EFFECTS OF OUTDOOR LIGHTING.
 - LIGHTING PROPOSAL TO COMPLY WITH AS1158.3.1. 2020 LIGHTING CATEGORIES AS FOLLOWS
-PA3 FOR PUBLIC ACTIVITY AREAS
 - LIGHTING PROPOSAL COMPLIES TO THE CRIME PREVENTION THROUGH ENVIRONMENTAL DESIGN GENERAL CODE.
 - CONTRACTOR TO CONFIRM FINAL LOCATION OF NEW FITTINGS ON LANDSCAPE SURVEY PLAN BEFORE COMMENCING WORK.
 - FINAL LIGHTING DESIGN TO BE CARRIED OUT BY A SUITABLE PERSON IN ACCORDANCE WITH LOCAL AUTHORITIES AND THE ABOVE STANDARDS.
 - GLARE SHALL BE CONTROLLED BY THE PROPER USE OF LIGHT DISTRIBUTION OPTIONS AND SHALL BE CONFIRMED BY THE LIGHTING DESIGNER AND THE MANUFACTURER
 - ALLOW TO LOCATE AND COORDINATE WITH ALL EXISTING UNDERGROUND SERVICES. MINIMUM CLEARANCES- 600mm HORIZONTAL & 150mm VERTICAL FROM ANY DRAINAGE PIPE. 500mm HORIZONTAL & 150mm VERTICAL FROM ANY WATER PIPE.
 - EXTERNAL ROADWAY LIGHTING IS EXCLUDED AND WILL BE PROVIDED BY THE LOCAL AUTHORITIES LIGHTING SCHEME.
 - ALL LED DRIVERS HAVE RCM CERTIFICATION AND ARE NATA ACCREDITED.
 - EXTERNAL LIGHTING TO BE CONTROLLED BY PHOTOELECTRIC CELL OR TIMER CLOCK AND/OR BOTH.
 - LIGHTING FIXTURE IMAGES PROVIDED ARE INDICATIVE ONLY.


ELECTRICAL - DRAWING LIST	
Drawing Number	Drawing Name
E01	LEGEND, GENERAL NOTES AND DRAWING LIST
E02	SITE PLAN - LIGHTING LAYOUT PART A
E03	SITE PLAN - LIGHTING LAYOUT PART B
E04	SITE PLAN - LIGHTING LAYOUT PART C
E05	SITE PLAN - LIGHTING LAYOUT PART D

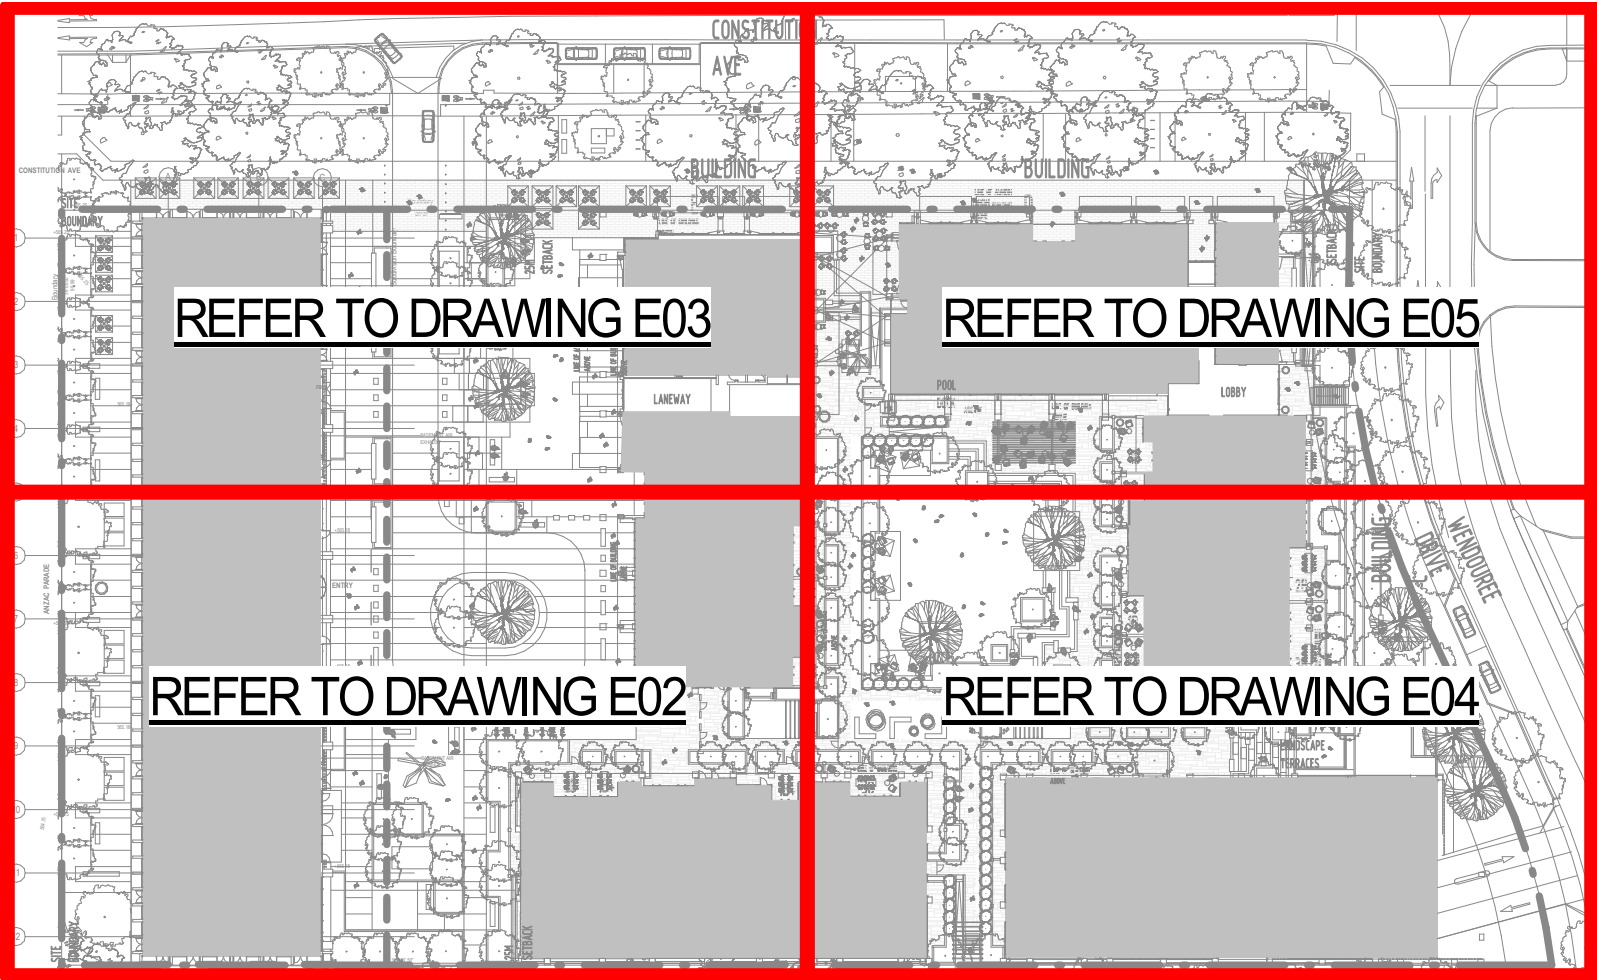

FOR INFORMATION ONLY

			ARCHITECT		CLIENT		SERVICES ENGINEER		PROJECT		DRAWING TITLE		SCALE: N.T.S.		DATE: 15.09.22	
									ANZAC PARK EAST BLOCK 2 SECTION 4 PARKES		ELECTRICAL SERVICES LEGEND, GENERAL NOTES AND DRAWING LIST		DRAWN: Author		DESIGNED: CC	
													NORTH		PROJECT No: 20220791	
															DRAWING No: E01	
															ISSUE: A	

REFER TO DRAWING E03

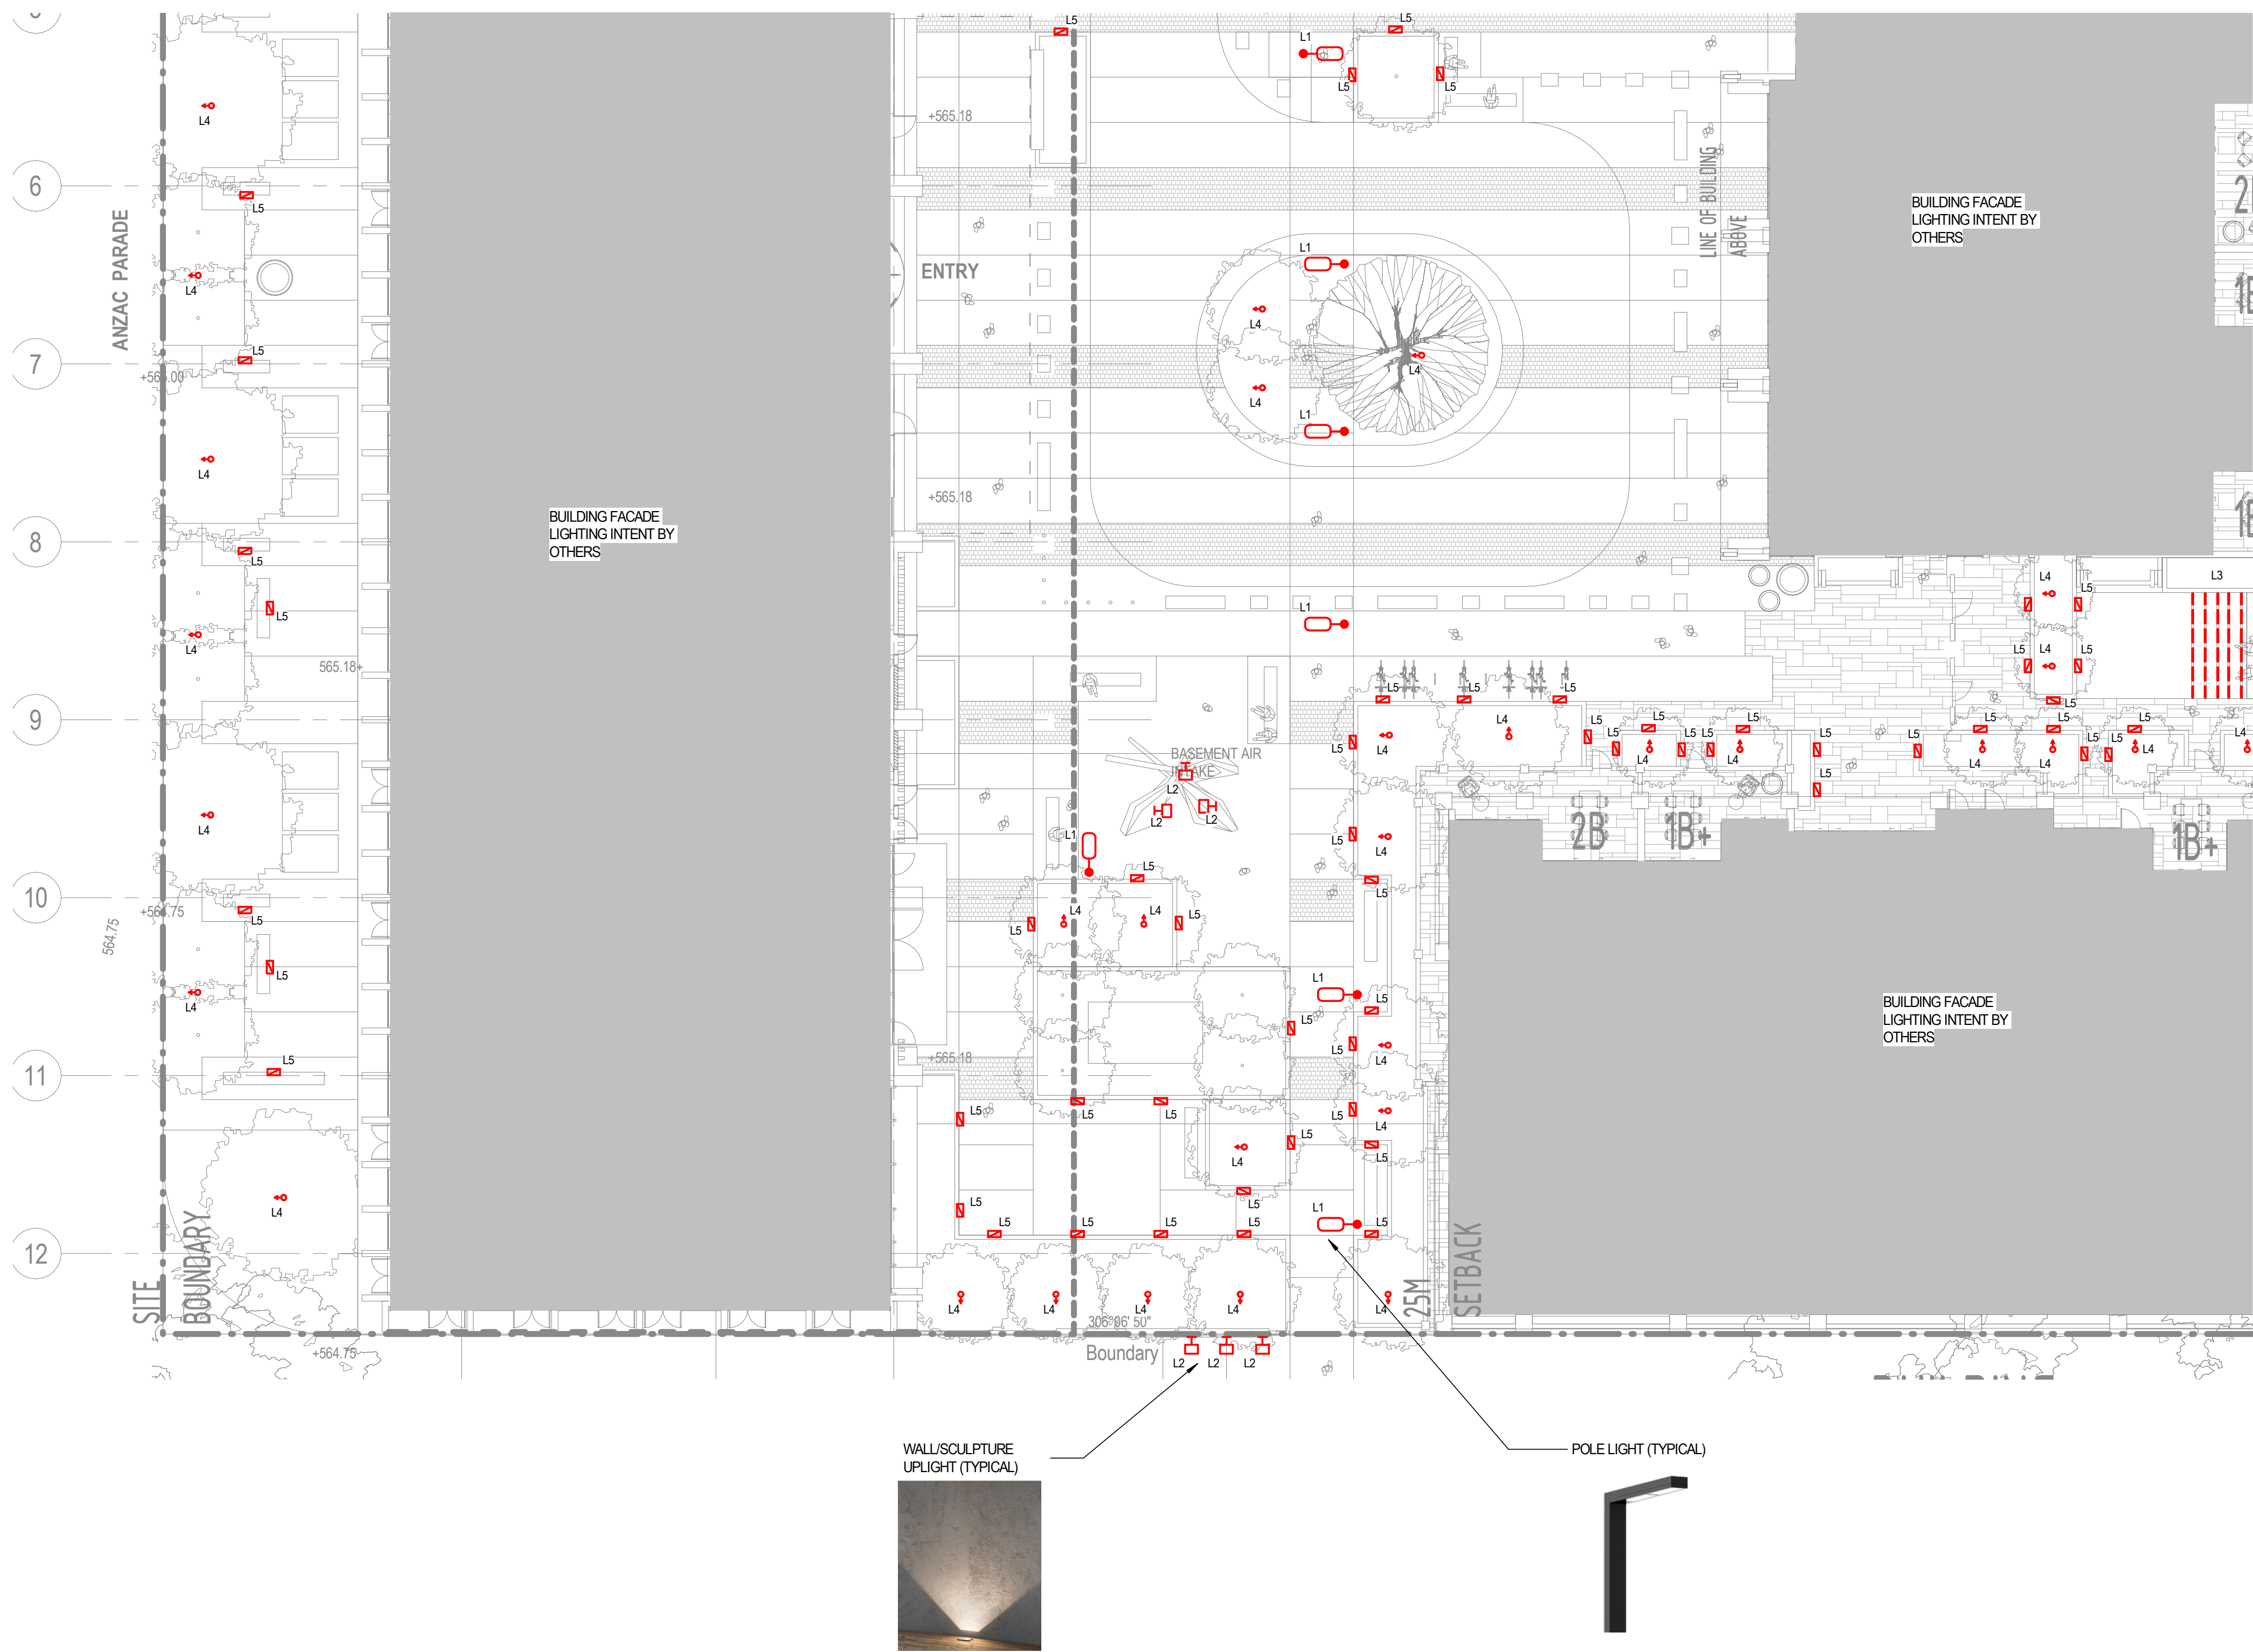

REFER TO DRAWING E04

FOR INFORMATION ONLY

REV	DESCRIPTION	DATE
A	PRELIMINARY ISSUE	15.09.22

15/09/2022 4:07:32 PM

ARCHITECT



CLIENT



SERVICES ENGINEER



PROJECT

ANZAC PARK EAST
BLOCK 2 SECTION 4 PARKES

DRAWING TITLE

ELECTRICAL SERVICES
SITE PLAN - LIGHTING LAYOUT
PART A


SCALE: 1 : 200

DATE: 15.09.22

DRAWN: Author

DESIGNED: CC

NORTH

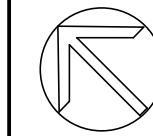

PROJECT No:

20220791


DRAWING No:

E02

ISSUE:


A

BIM 360://20220791 - Eastbourne/20220791 - Eastbourne-MEP_RVT19Central.rvt

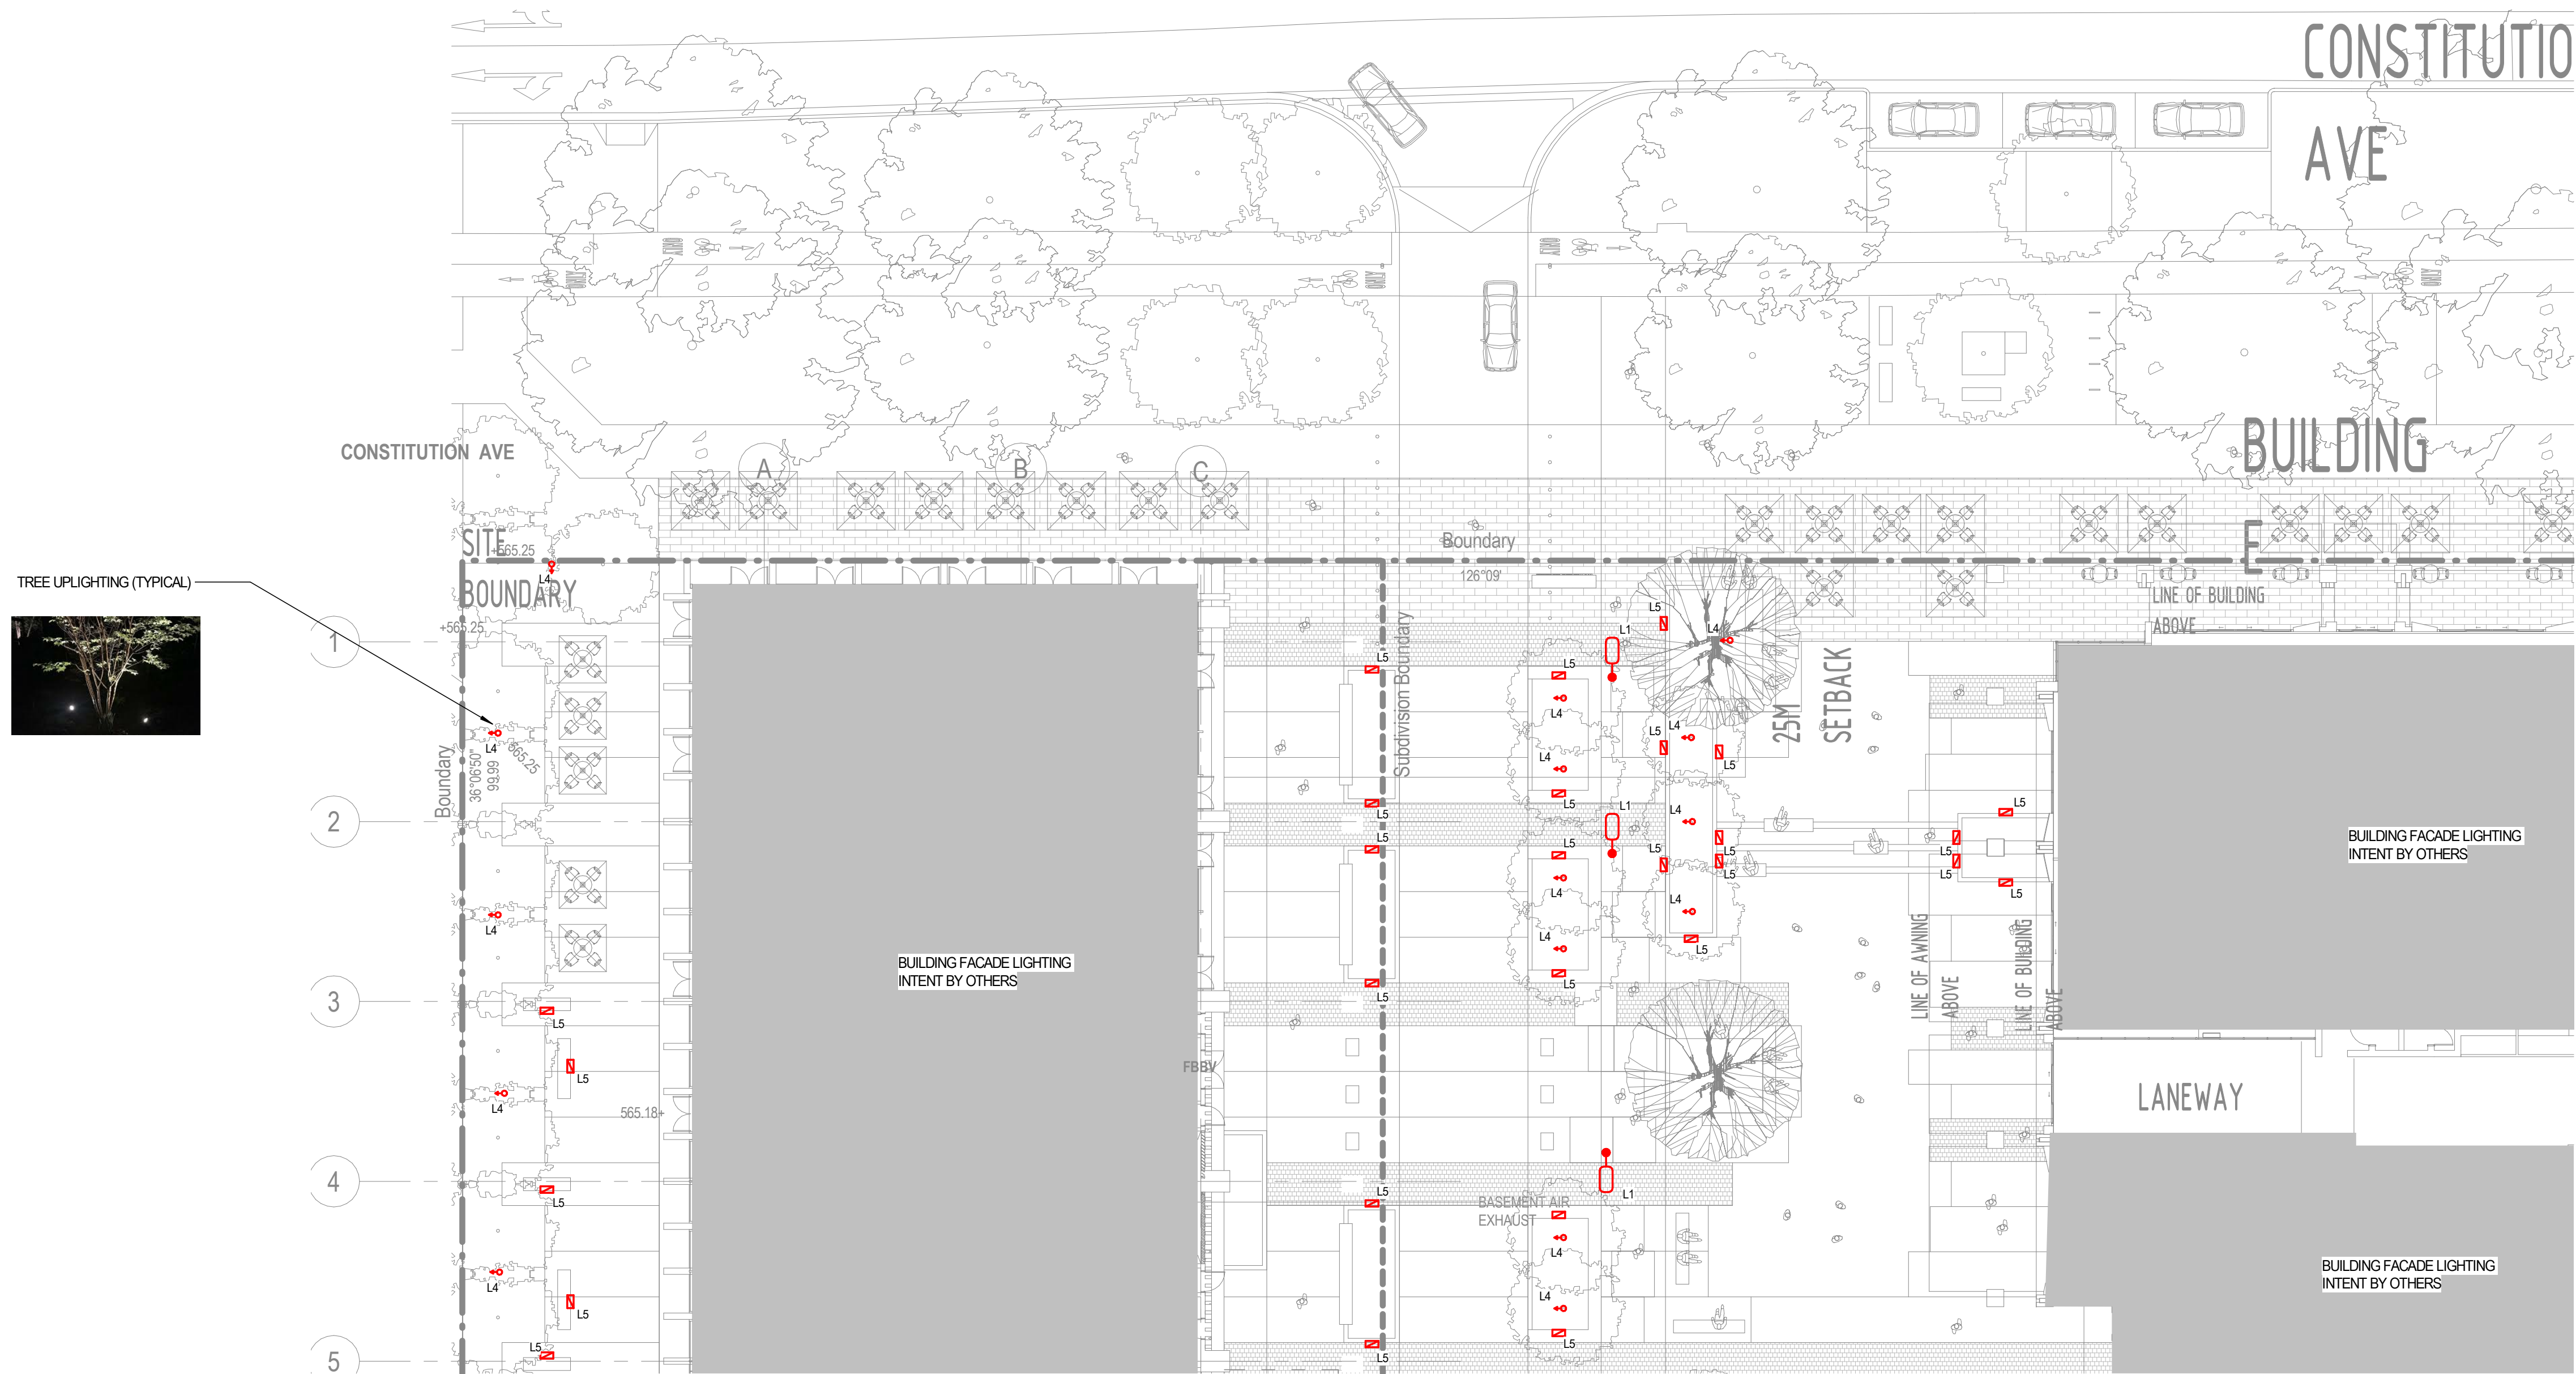

REFER TO DRAWING E05

 REFER TO DRAWING E02



FOR INFORMATION ONLY

REV	DESCRIPTION	DATE
A	PRELIMINARY ISSUE	15.09.22

15/09/2022 4:07:41 PM

ARCHITECT



CLIENT



SERVICES ENGINEER



PROJECT

ANZAC PARK EAST
BLOCK 2 SECTION 4 PARKES

DRAWING TITLE

ELECTRICAL SERVICES
SITE PLAN - LIGHTING LAYOUT
PART B


SCALE: 1 : 200

DATE: 15.09.22

DRAWN: Author

DESIGNED: CC

NORTH

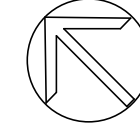

PROJECT No:

20220791

DRAWING No:


E03

ISSUE:

A

REFER TO DRAWING E05


REFER TO DRAWING E02

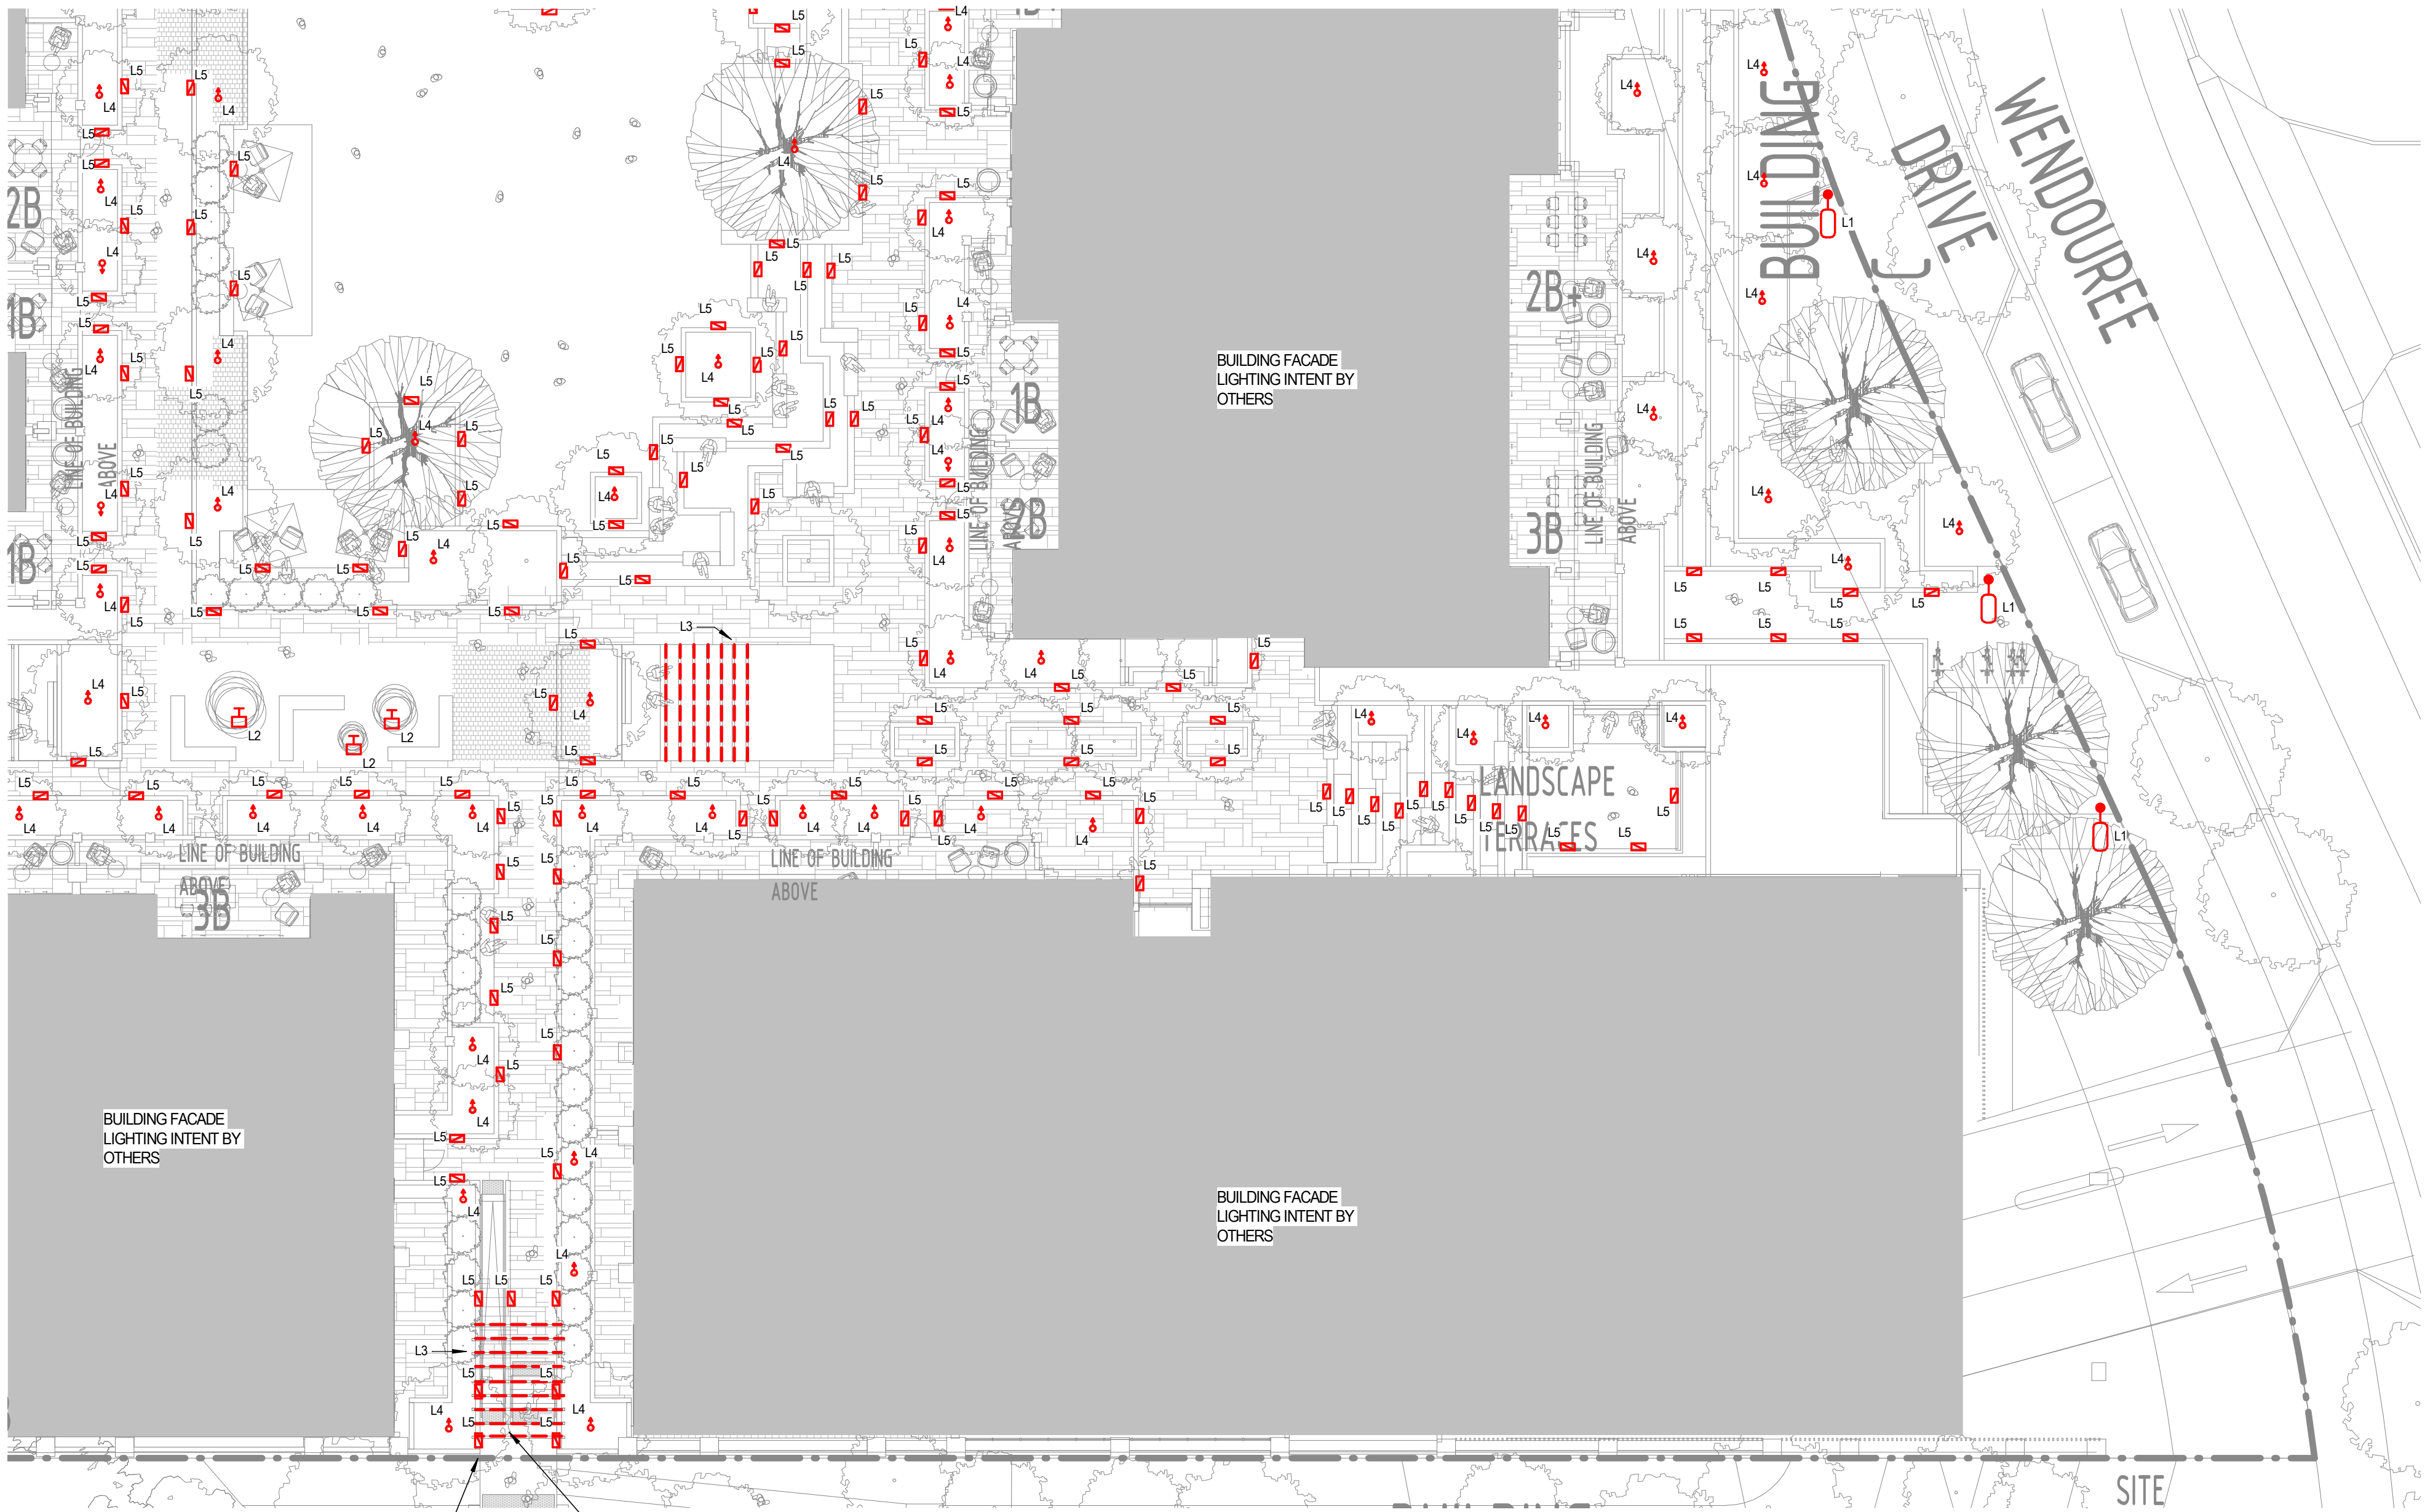

RECESSED WALL LIGHT (TYPICAL)



 
ARBOUR FRAME LINEAR DOWNLIGHT (TYPICAL)



REV	DESCRIPTION	DATE
A	PRELIMINARY ISSUE	15.09.22

15/09/2022 4:07:52 PM

ARCHITECT

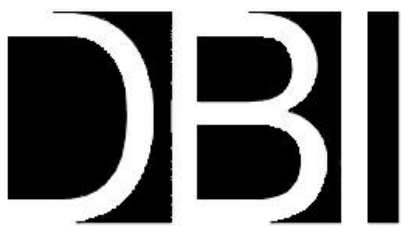

© DBI DESIGN PTY LTD

CLIENT



SERVICES ENGINEER



Level 3, 33-35, Ainslie Place
Canberra ACT 2601 ABN: 15 622 958 721
Tel: 02 6262 8252 Email: mail@bse.com.au
www.bse.com.au

PROJECT

ANZAC PARK EAST
BLOCK 2 SECTION 4 PARKES

CONTRACTOR MUST CHECK ALL DIMENSIONS ON SITE BEFORE COMMENCING ANY WORK OR PREPARING ANY SHOP DRAWINGS. SHOP DRAWINGS MUST BE SUBMITTED AND APPROVED BEFORE MANUFACTURE. THIS DRAWING IS THE PROPERTY OF BUILDING SERVICES ENGINEERS AND SUBJECT TO RETURN ON REQUEST.

DRAWING TITLE

ELECTRICAL SERVICES
SITE PLAN - LIGHTING LAYOUT
PART C

SCALE: 1 : 200

DRAWN: Author



DATE: 15.09.22

DESIGNED: CC

PROJECT No:


20220791

DRAWING No:


E04

ISSUE:

A

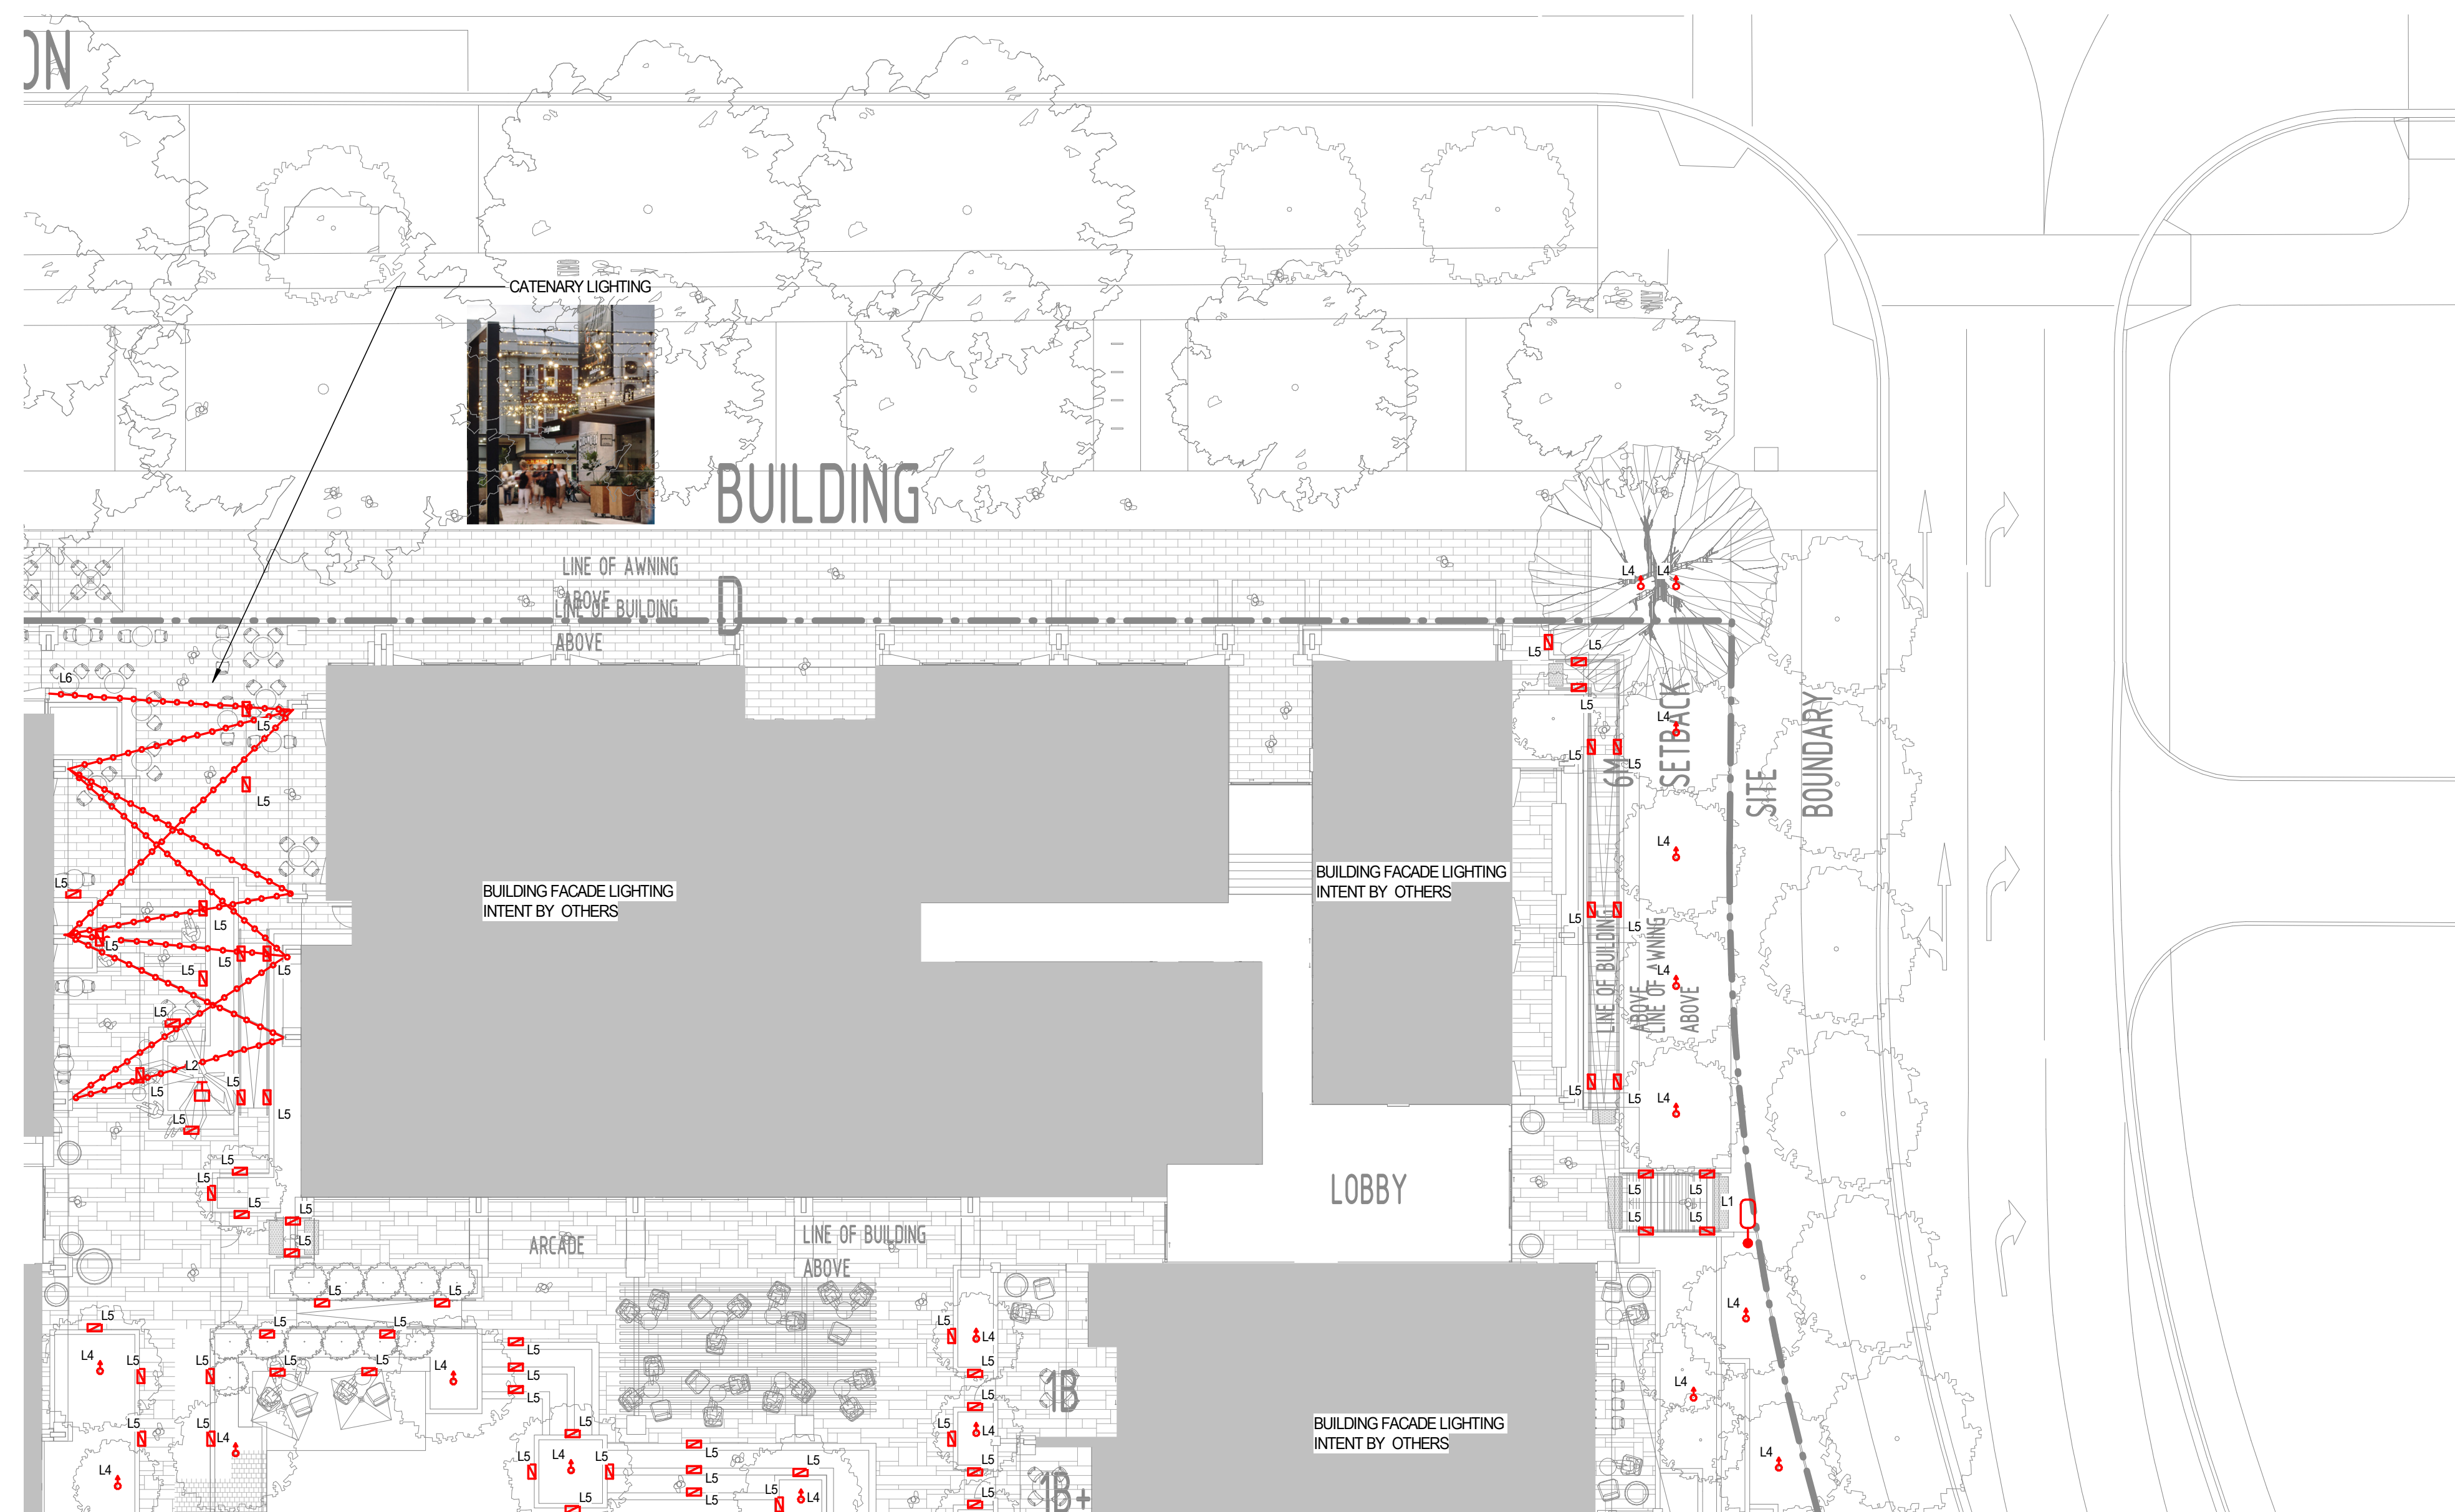

REFER TO DRAWING E04

 

A	PRELIMINARY ISSUE	15.09.22
REV	DESCRIPTION	DATE

ARCHITECT

CLIENT



	SERVICES ENGINEER
--	-------------------



	PROJECT
--	---------

ANZAC PARK EAST
BLOCK 2 SECTION 4 PARKES

CONTRACTOR MUST CHECK ALL DIMENSIONS ON SITE BEFORE COMMENCING ANY WORK OR PREPARING ANY SHOP DRAWINGS. SHOP DRAWINGS MUST BE SUBMITTED AND APPROVED BEFORE MANUFACTURE. THIS DRAWING IS THE PROPERTY OF BUILDING SERVICES ENGINEERS AND SUBJECT TO RETURN ON REQUEST.

	DRAWING TITLE
--	---------------

ELECTRICAL SERVICES
SITE PLAN - LIGHTING LAYOUT
PART D

SCALE:

1 : 200
DRAWN: Author

DATE: 11-22-00

	15.09.22
DESIGNED:	CC

NORTH	PROJECT No: 20220791	DRAWING No: E05	ISSUE: A
-------	-----------------------------	------------------------	-----------------