


NOTES:

1.
- AREAS WITH THIS NOTE SHALL HAVE LIGHTING PROVIDED BY BOLLARDS AND WALL/BRICK LIGHTS TO SUIT THE FINAL LANDSCAPE DESIGN AND THE LIGHTING CATEGORY IDENTIFIED ON DRAWING 117094-E120.
2.
- LOCATIONS WITH THIS NOTE SHALL HAVE ILLUMINATED BUILDING SIGNAGE. SIGNAGE LIGHTING SHALL BE DESIGNED TO MINIMISE UPWARD WASTE LIGHT.

LIGHTING

SYMBOL	DESCRIPTION	REQUIREMENTS
	NEW SINGLE OR DOUBLE LED POST TOP LUMINAIRE MOUNTED ON A 6m POLE.	
	NEW 'A' TYPE LUMINAIRE MOUNTED ON THE BUILDING AT 6m AFGl.	
	NEW LED IP54 DOWNLIGHT.	
	NEW LED BOLLARD LUMINAIRE.	
	LED BATTEN TYPE LUMINAIRES. REFER TO DRAWING 118410-E121.	

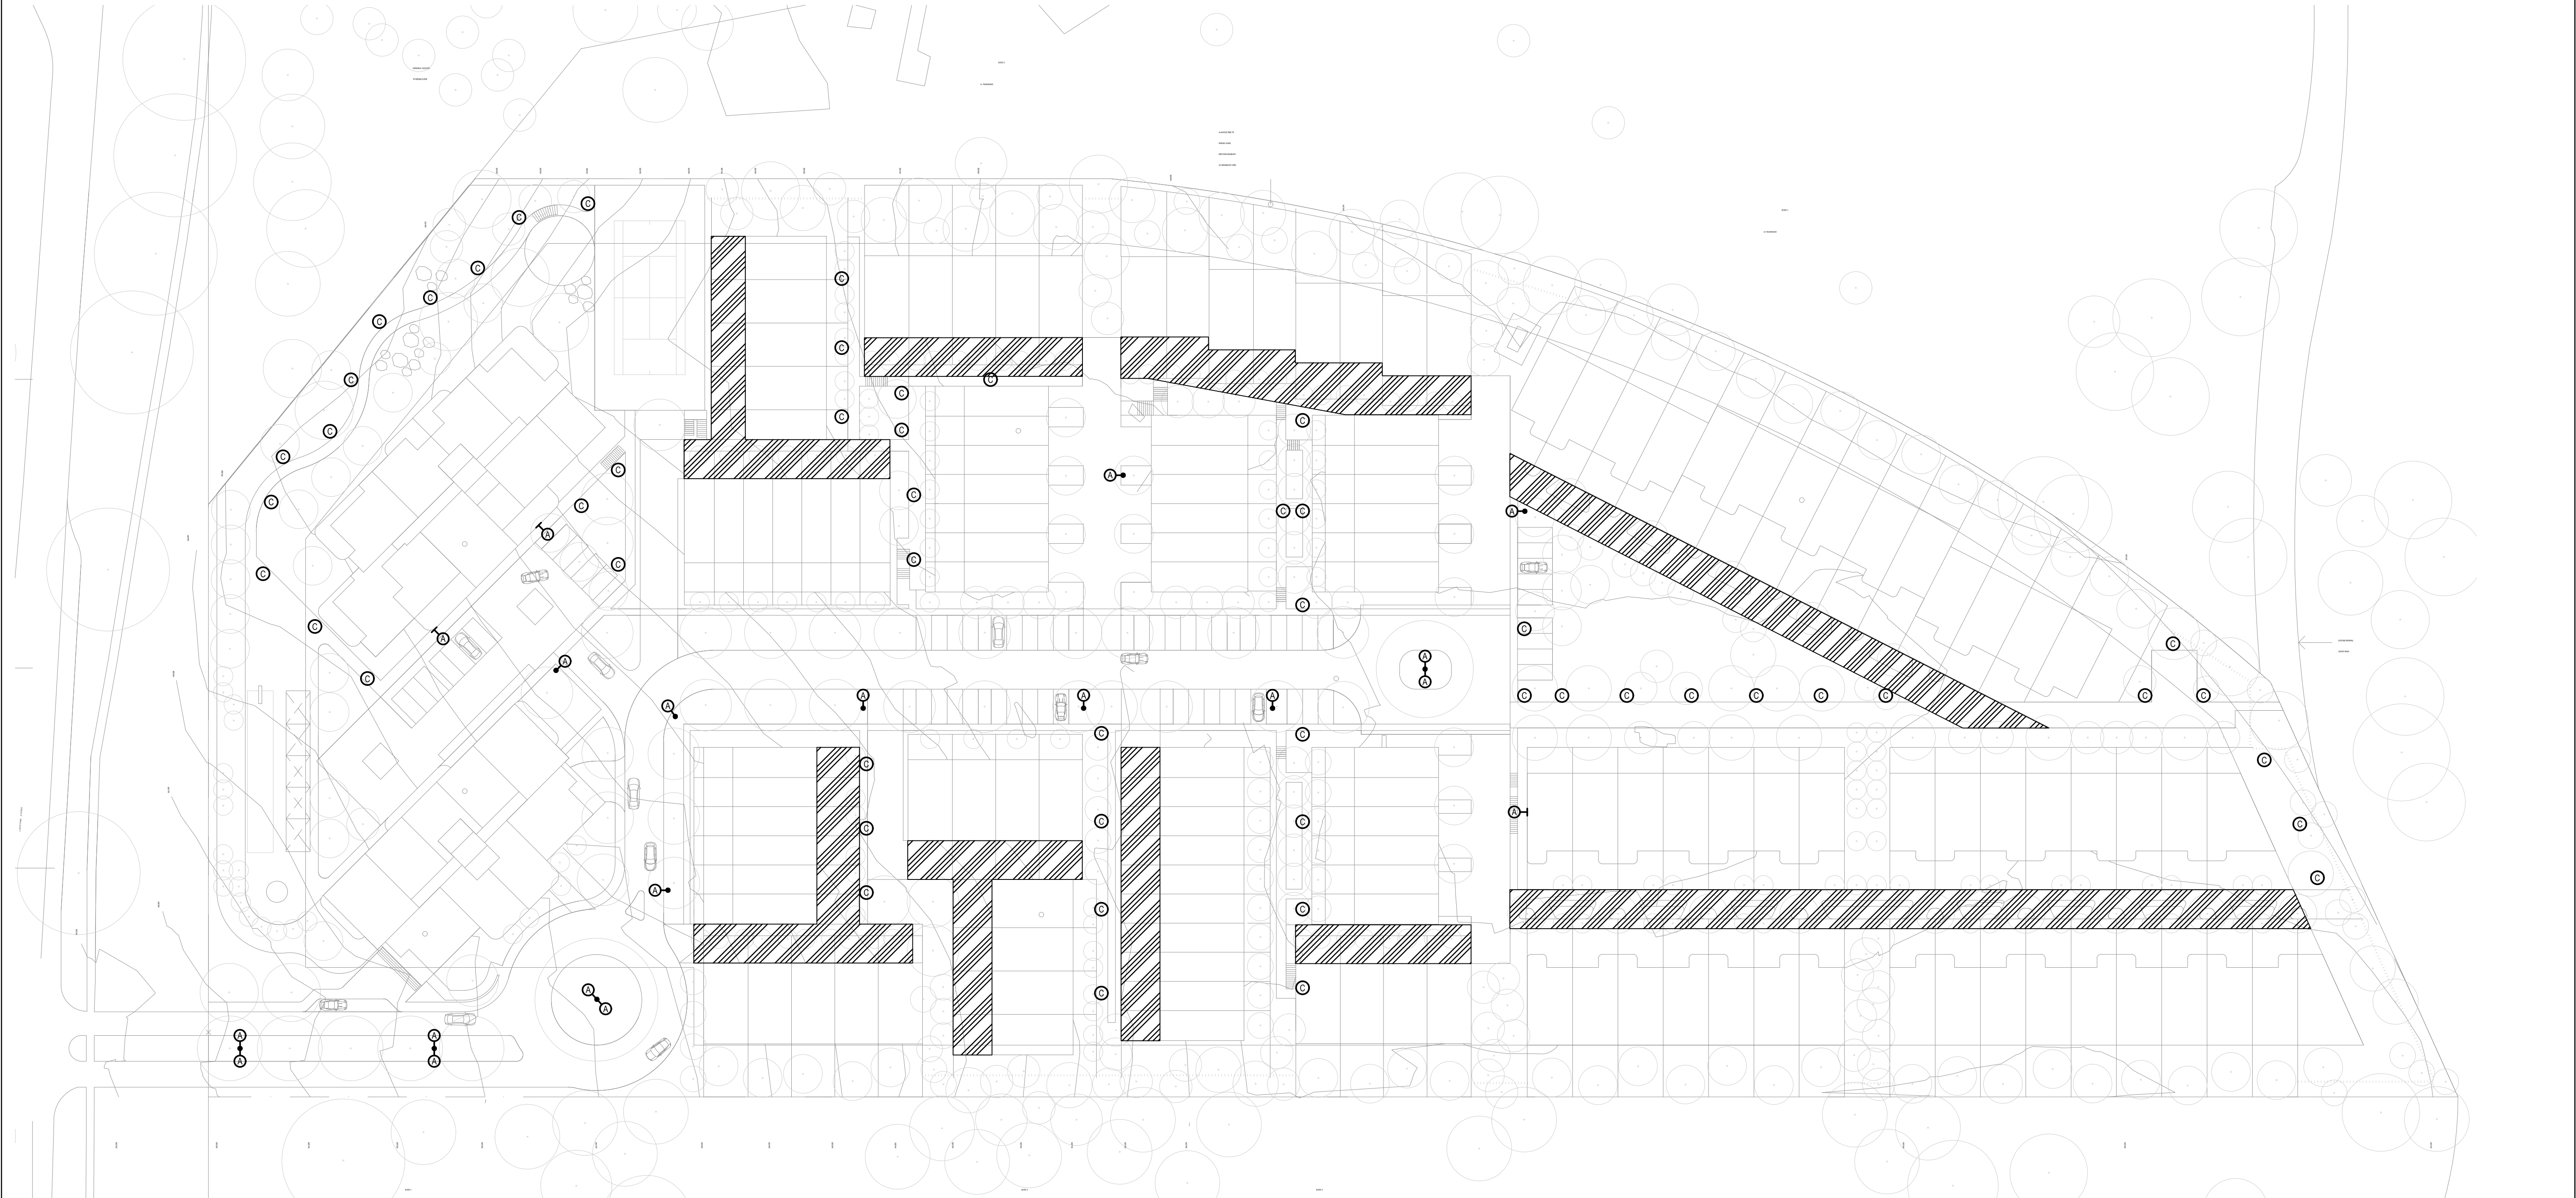

0422.05.19REISSUE FOR CONCEPT DESIGN - REV BJT				<div>NOT FOR TENDER</div> <p>©COPYRIGHT RUDD'S CONSULTING ENGINEERS PTY LTD (DATE OF ISSUE) REPRODUCTION OF THE WHOLE OR PART OF THE DOCUMENT CONSTITUTES AN INFRINGEMENT OF COPYRIGHT. THE INFORMATION, IDEAS AND CONCEPTS CONTAINED IN THIS DOCUMENT ARE CONFIDENTIAL. THE RECIPIENT (S) OF THIS DOCUMENT IS/ARE PROHIBITED FROM DISCLOSING SUCH INFORMATION, IDEAS AND CONCEPTS TO ANY PERSON WITHOUT THE PRIOR WRITTEN CONSENT OF THE COPYRIGHT HOLDER</p>	<div><p>5 Bodalla Place FYSHWICK, ACT 2609 Tel: (02) 6240 2900 Fax: (02) 6280 9951 Email: <a href="mailto:firstname.surname@rudds.com.au">firstname.surname@rudds.com.au</a> Website: <a href="http://www.rudds.com.au">www.rudds.com.au</a></p></div> <div><table><tr><td>Designed P. McKenzie</td><td>Reviewed / Date L. Forner 22.05.19</td><td>Approved / Date L. Forner 22.05.19</td></tr><tr><td>Drawn J. Thilakasi</td><td>AutoCAD Drawing 118410-E150 [04]</td><td></td></tr></table></div>	Designed P. McKenzie	Reviewed / Date L. Forner 22.05.19	Approved / Date L. Forner 22.05.19	Drawn J. Thilakasi	AutoCAD Drawing 118410-E150 [04]		<div>Client</div> <div></div>	<div>Project</div> <div>CAMPBELL, SECTION 38, BLOCK 4 AND 5</div>	<div>Drawing Title</div> <div>SITE PLAN EXTERNAL LIGHTING LAYOUT ELECTRICAL SERVICES</div>	<table><tr><td>Scale</td><td>Sht Size</td><td>Drawing No.</td><td>Rev.</td></tr><tr><td>1:500</td><td>A1</td><td>118410-E150</td><td>04</td></tr></table>	Scale	Sht Size	Drawing No.	Rev.	1:500	A1	118410-E150	04
Designed P. McKenzie	Reviewed / Date L. Forner 22.05.19					Approved / Date L. Forner 22.05.19																	
Drawn J. Thilakasi	AutoCAD Drawing 118410-E150 [04]																						
Scale	Sht Size					Drawing No.	Rev.																
1:500	A1	118410-E150	04																				
0323.01.19REISSUE FOR CONCEPT DESIGNNF																							
0222.01.19REISSUE FOR CONCEPT DESIGNJT																							
0124.08.18ISSUE FOR CONCEPT DESIGNDO																							
Rev.	Date	Details and Status	By	Rev.	Date	Details and Status	By																